


ATTACHMENT 1

LANDLORD PLAN WITH ELECTRICAL ROOM 24 CDW SUITE 100 & 105

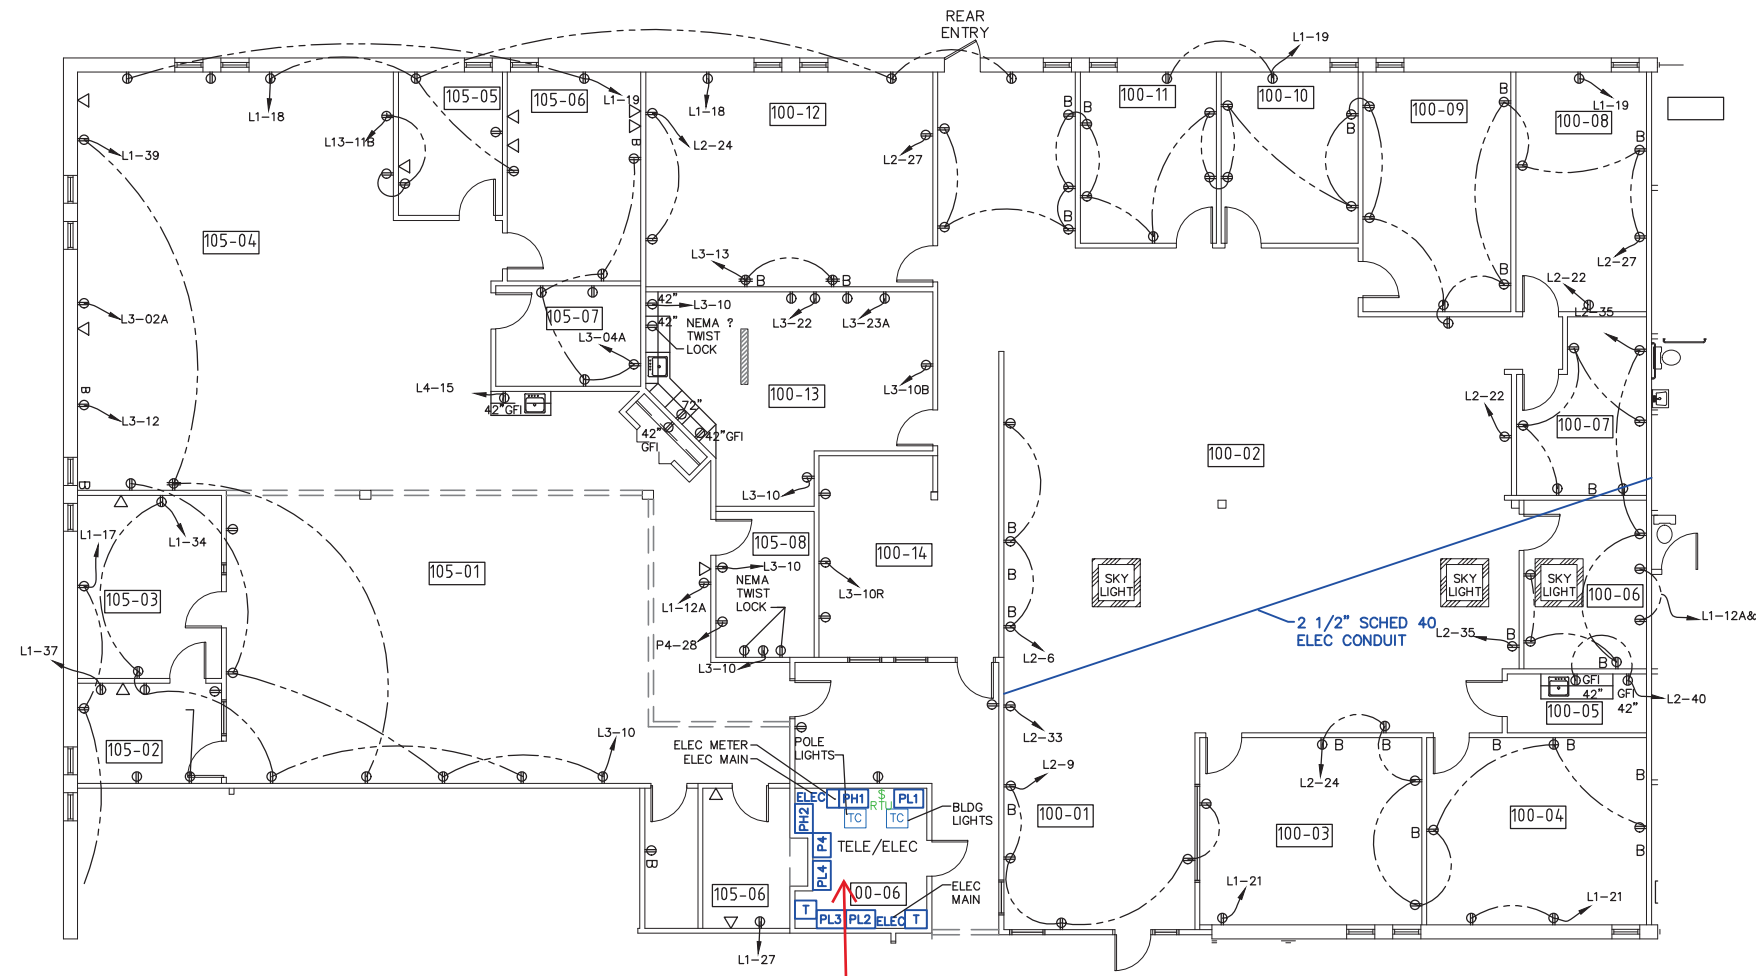

Building's Electrical Room

SUITES 100 + 105 ELECTRICAL PLAN

SCALE = 1/16"=1'-0"
 ALL WALL LOCATIONS AND ROOM
 DIMENSIONS REQUIRE FIELD VERIFICATION

LEGEND

- ⊕ GENERAL USE OUTLET
- ⊕_D DEDICATED OUTLET
- ⊕_{IG} ISOLATED GROUND OUTLET
- ⊕_{GFI} GROUND FAULT INTERRUPT OUTLET
- ⊕_{42"} # DENOTES ANY OUTLET ABOVE STANDARD FLOOR ELEVATION.
- ⊕₄ QUAD OUTLET
- ◁ TELE/DATA JACK
- B BLANK OFF PLATE
- ELECTRICAL OUTLET WIRING
- ↪ PANEL BREAKER NUMBER DESIGNATION
- TC TIME CLOCK

